


Russell Street Town Houses

Russell Street – Boston, Massachusetts

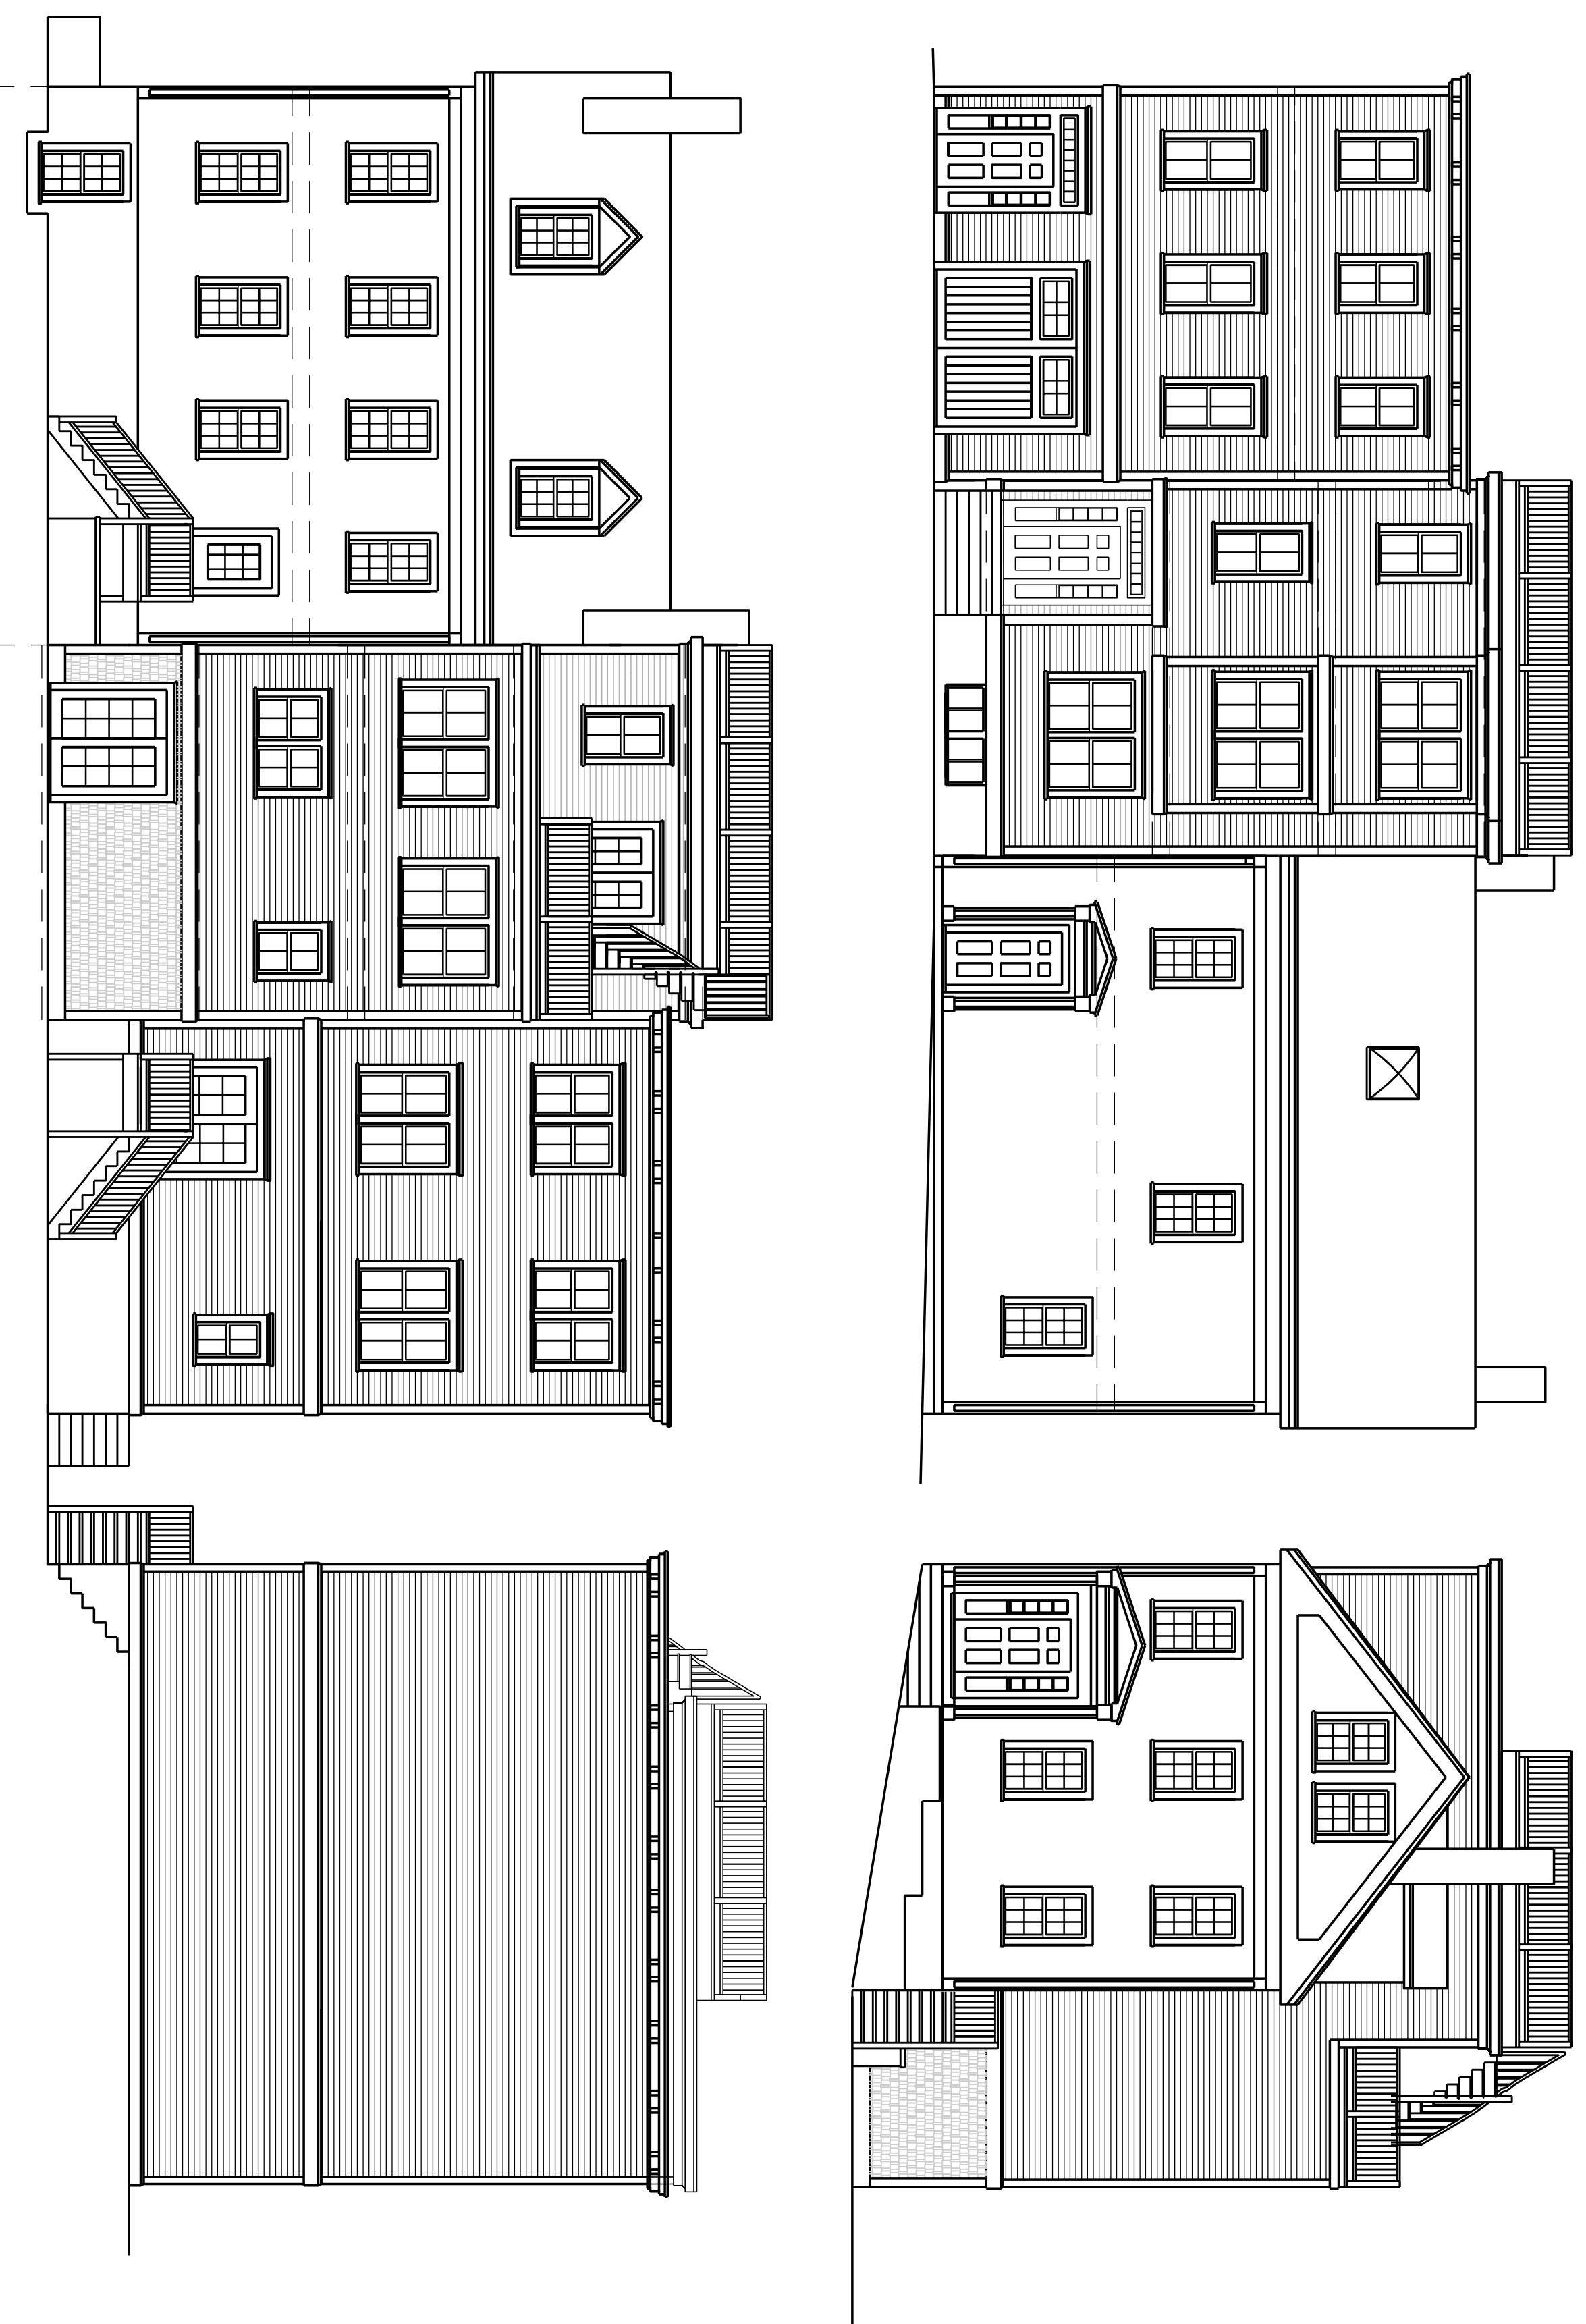

List of Drawings:

Title Sheet	
EX1	Existing Floor Plans
L1	Architectural Site Plan
A1	Basement & 1st Floor Plan
A2	2nd, 3rd Floor Plan & Wall Types
A3	Exterior Elevations
A4	Basement, 1st Floor Power Plan
A5	2nd & 3rd Floor Power Plan
S1	Foundation Plan & Details
S2	1st, 2nd Floor Framing Plans & Details
S2	3rd Floor, Roof Framing Plan & Details
S3	Building Section & Details

New Gross Floor Area/s

Basement	1,309 s.f.	– (excluded)
1st Floor	1,967 s.f.	– gross floor area
2nd Floor	2,299 s.f.	– gross floor area
3rd Floor	2,038 s.f.	– gross area
Gross Floor Area	7,613 s.f.	
Lot Area	4,150 s.f.	
Floor Area Ratio	1.80	F.A.R.

Architect:

AESTHETIC IMAGES


Architects / Planners

7 Stimson Street
Boston, MA 02132


Phone: (617) 323-6081
Fax: (617) 323-6081

Permit Document 04/21/2016


Permit Document Revisd 08/06/2016

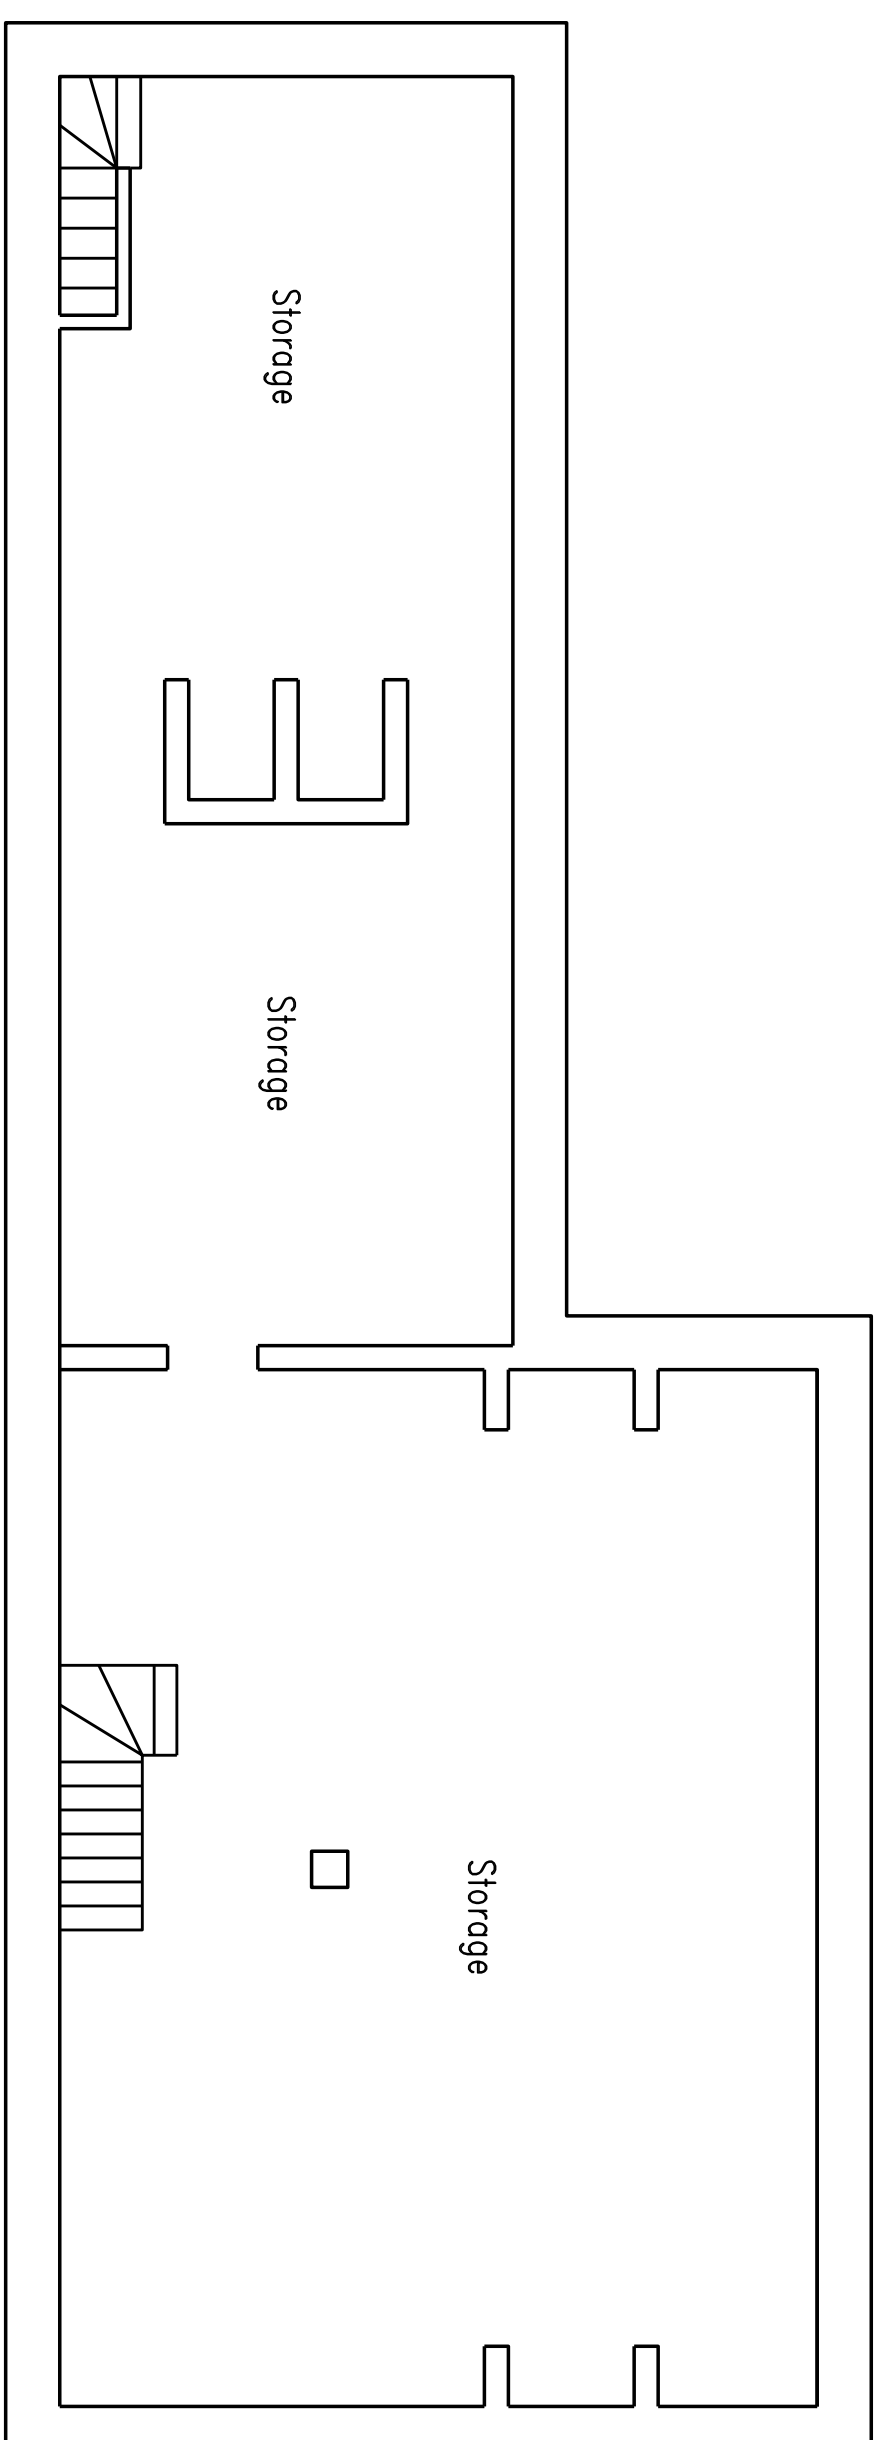


1
Scale: 1/4" = 1'-0"

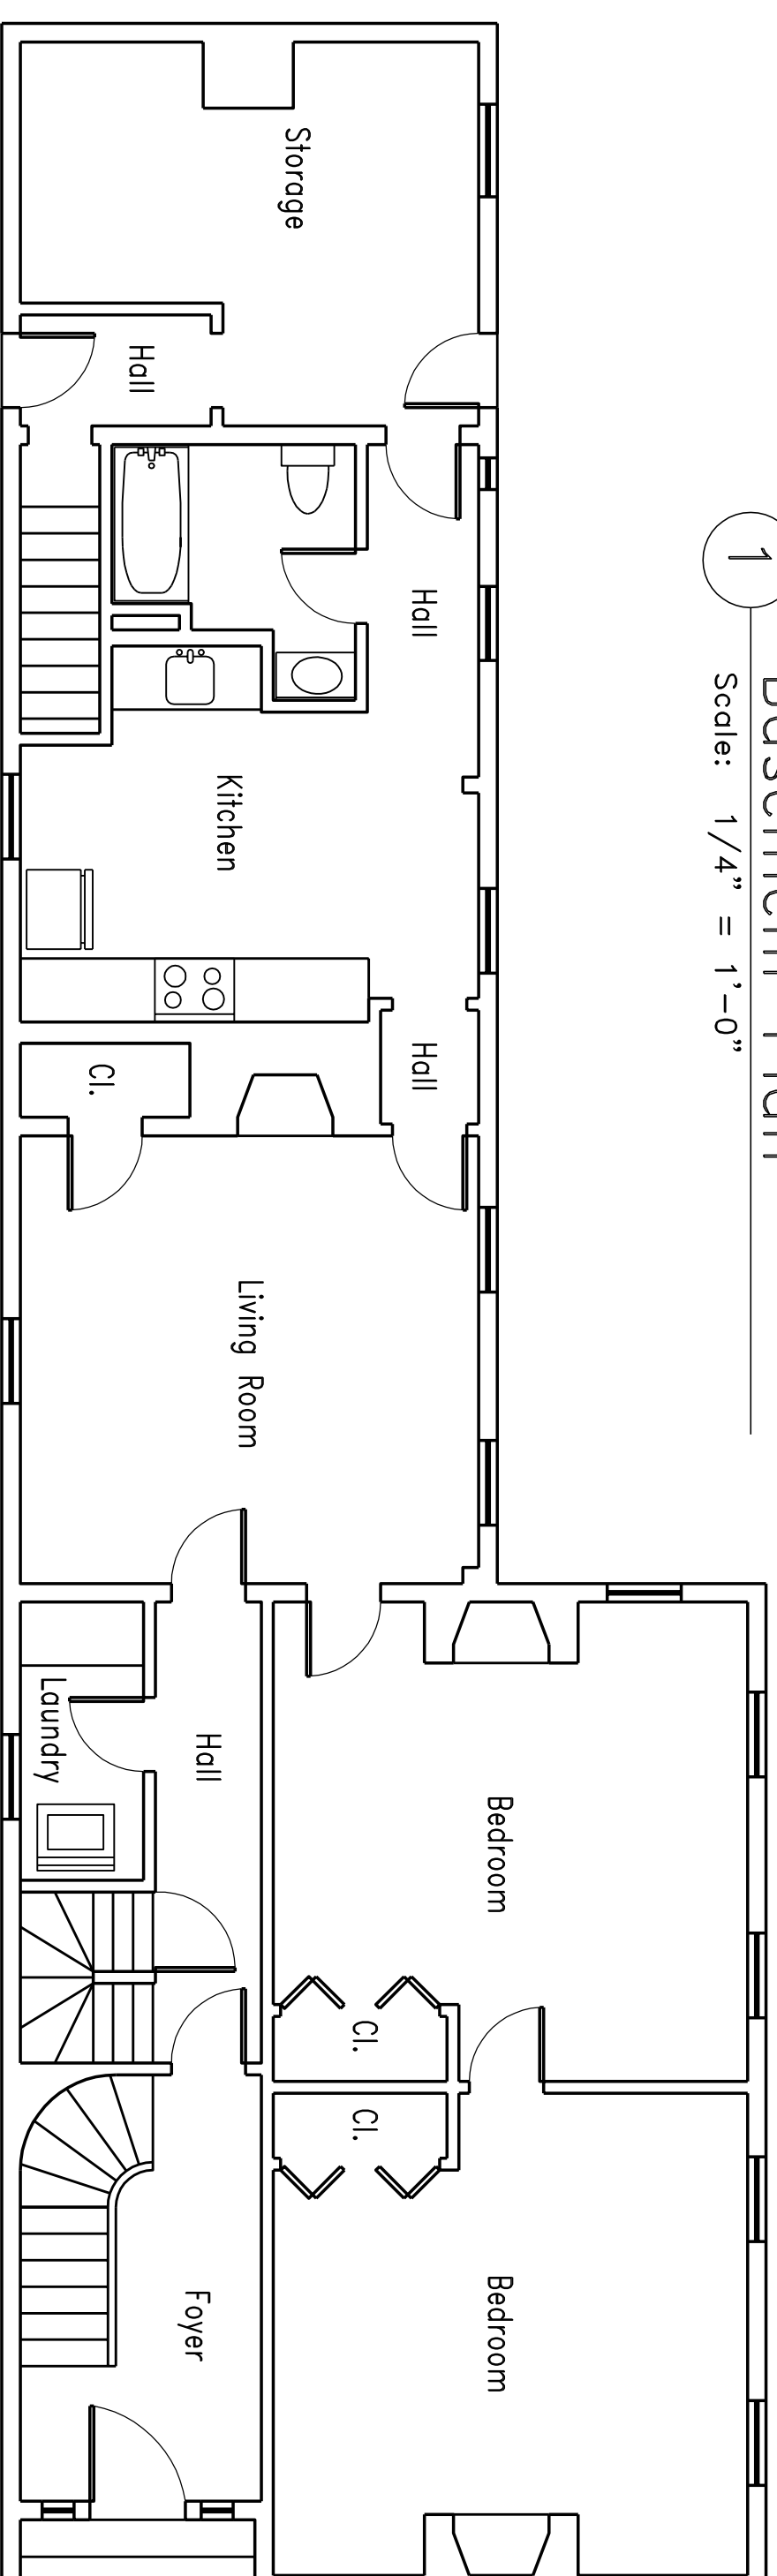

2
Scale: 1/4" = 1'-0"

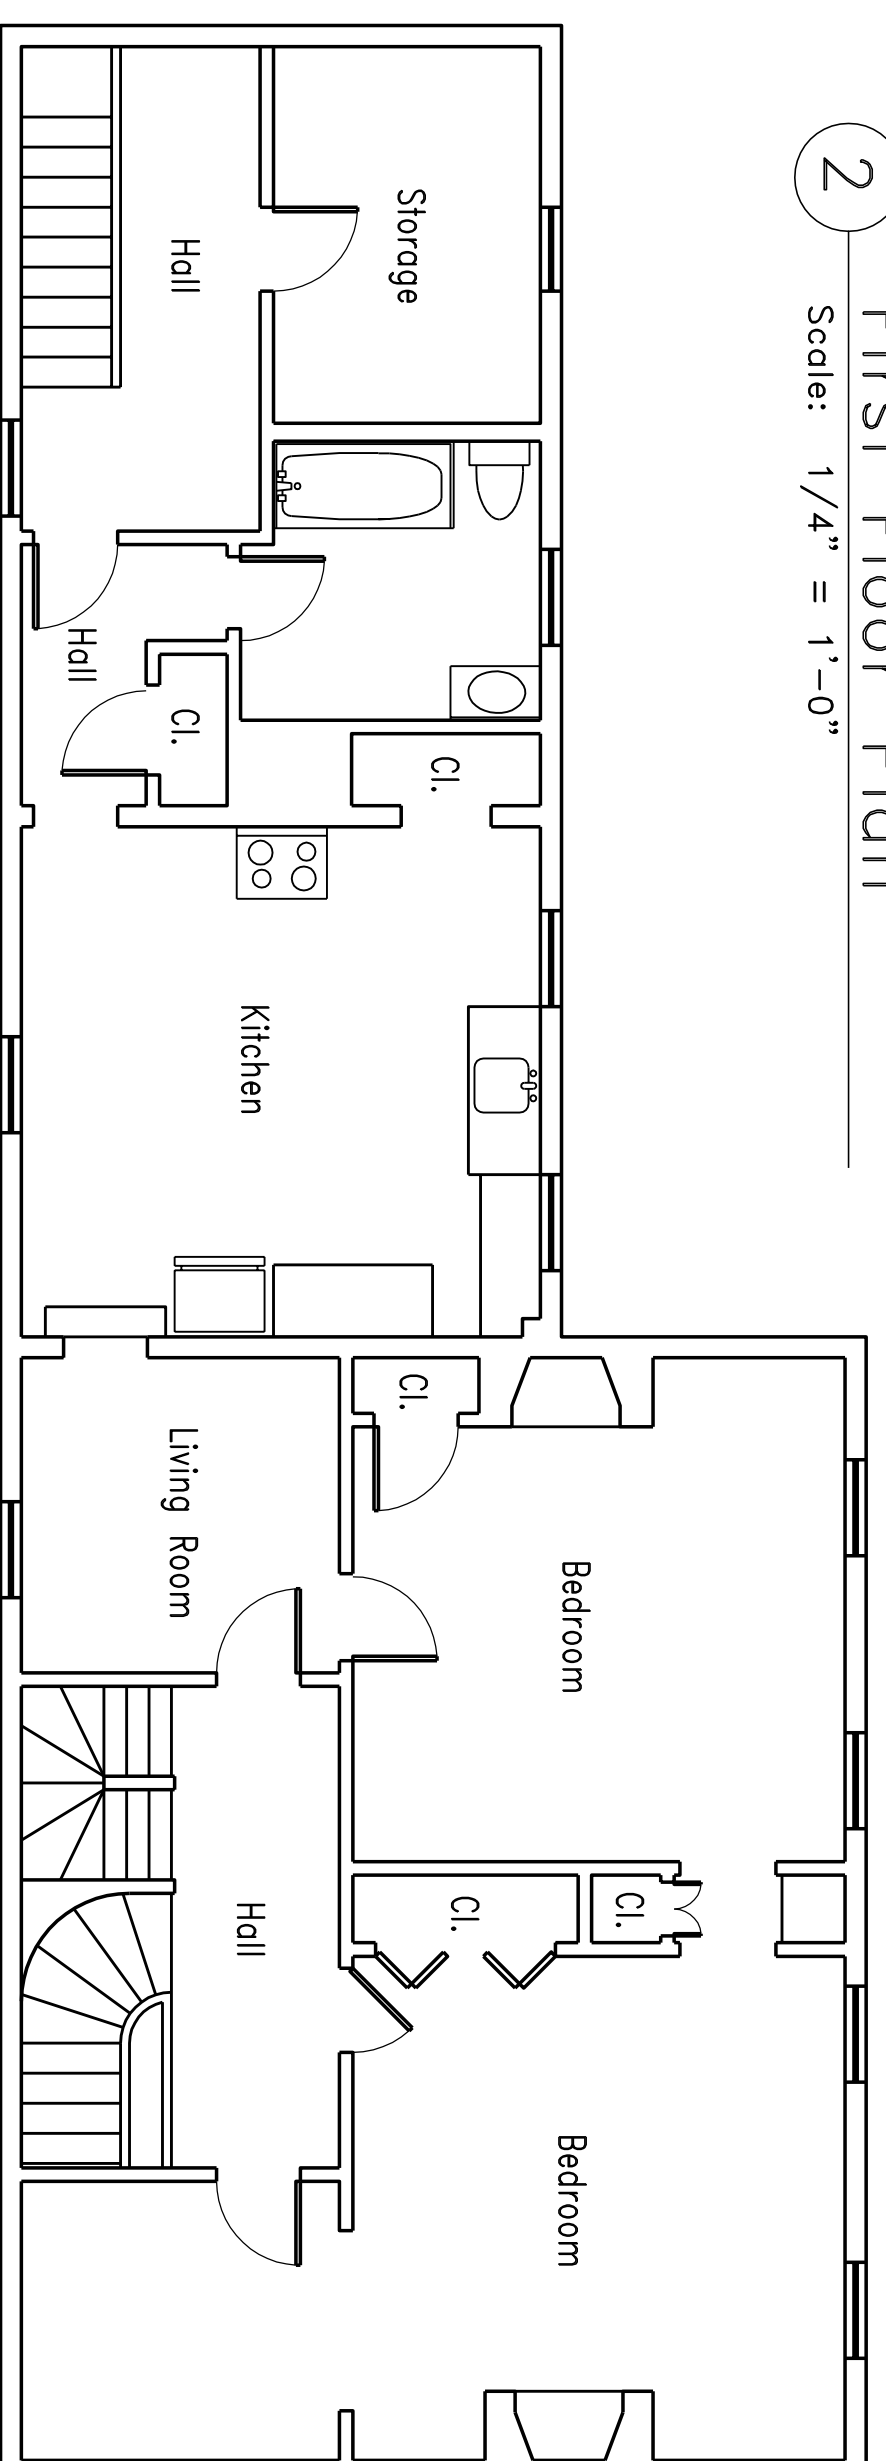


3
Scale: 1/4" = 1'-0"

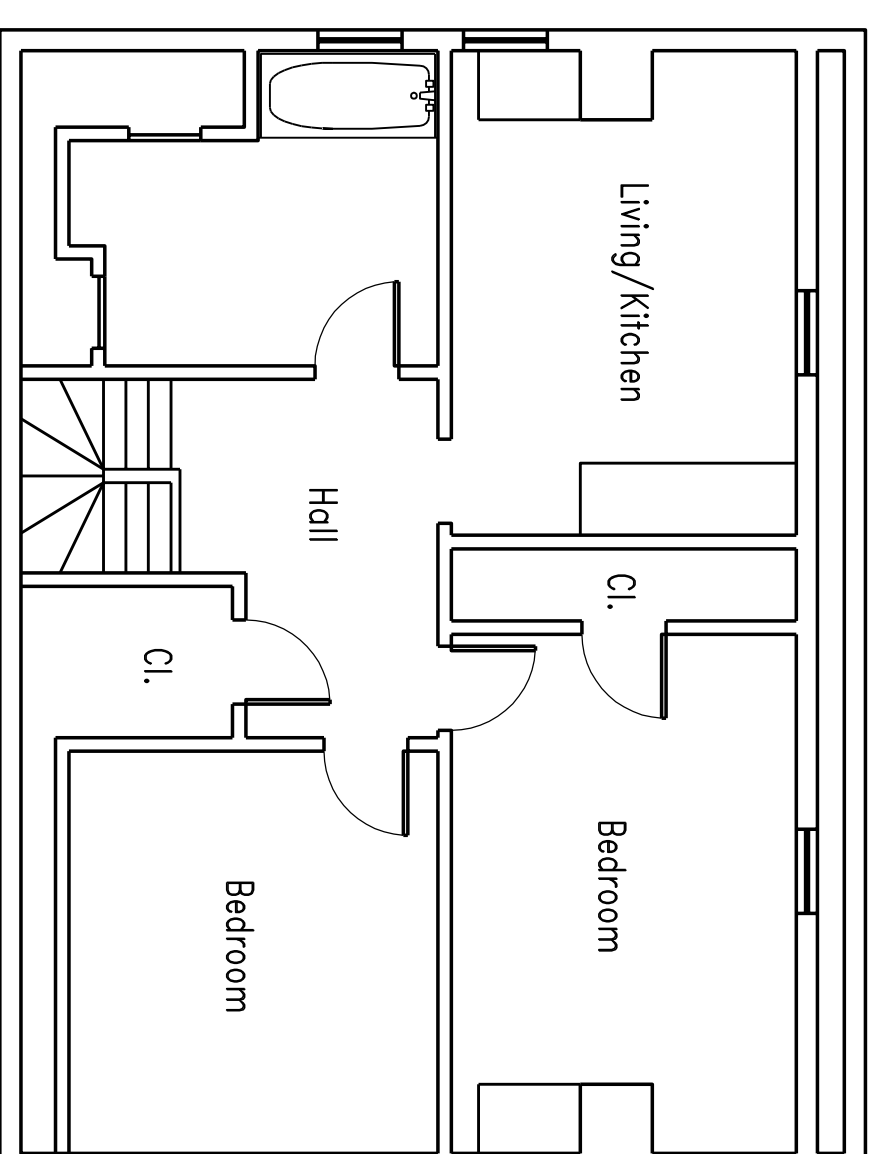

4
Scale: 1/4" = 1'-0"

north arrow

AESTHETIC IMAGES
Architects / Planners
7 Stimson Street
Boston, Massachusetts 02132
Phone: (617) 323-4955
Fax: (617) 323-6081

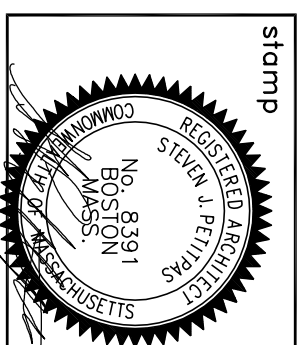


Project: Russell Street Town Houses
Russell Street
Charlestown, Massachusetts

revisions	date


date: 04/21/2016
scale: 1/4" = 1'-0"
drawn: SJP
job no.:

title: Existing Floor Plans

sheet no. EX1

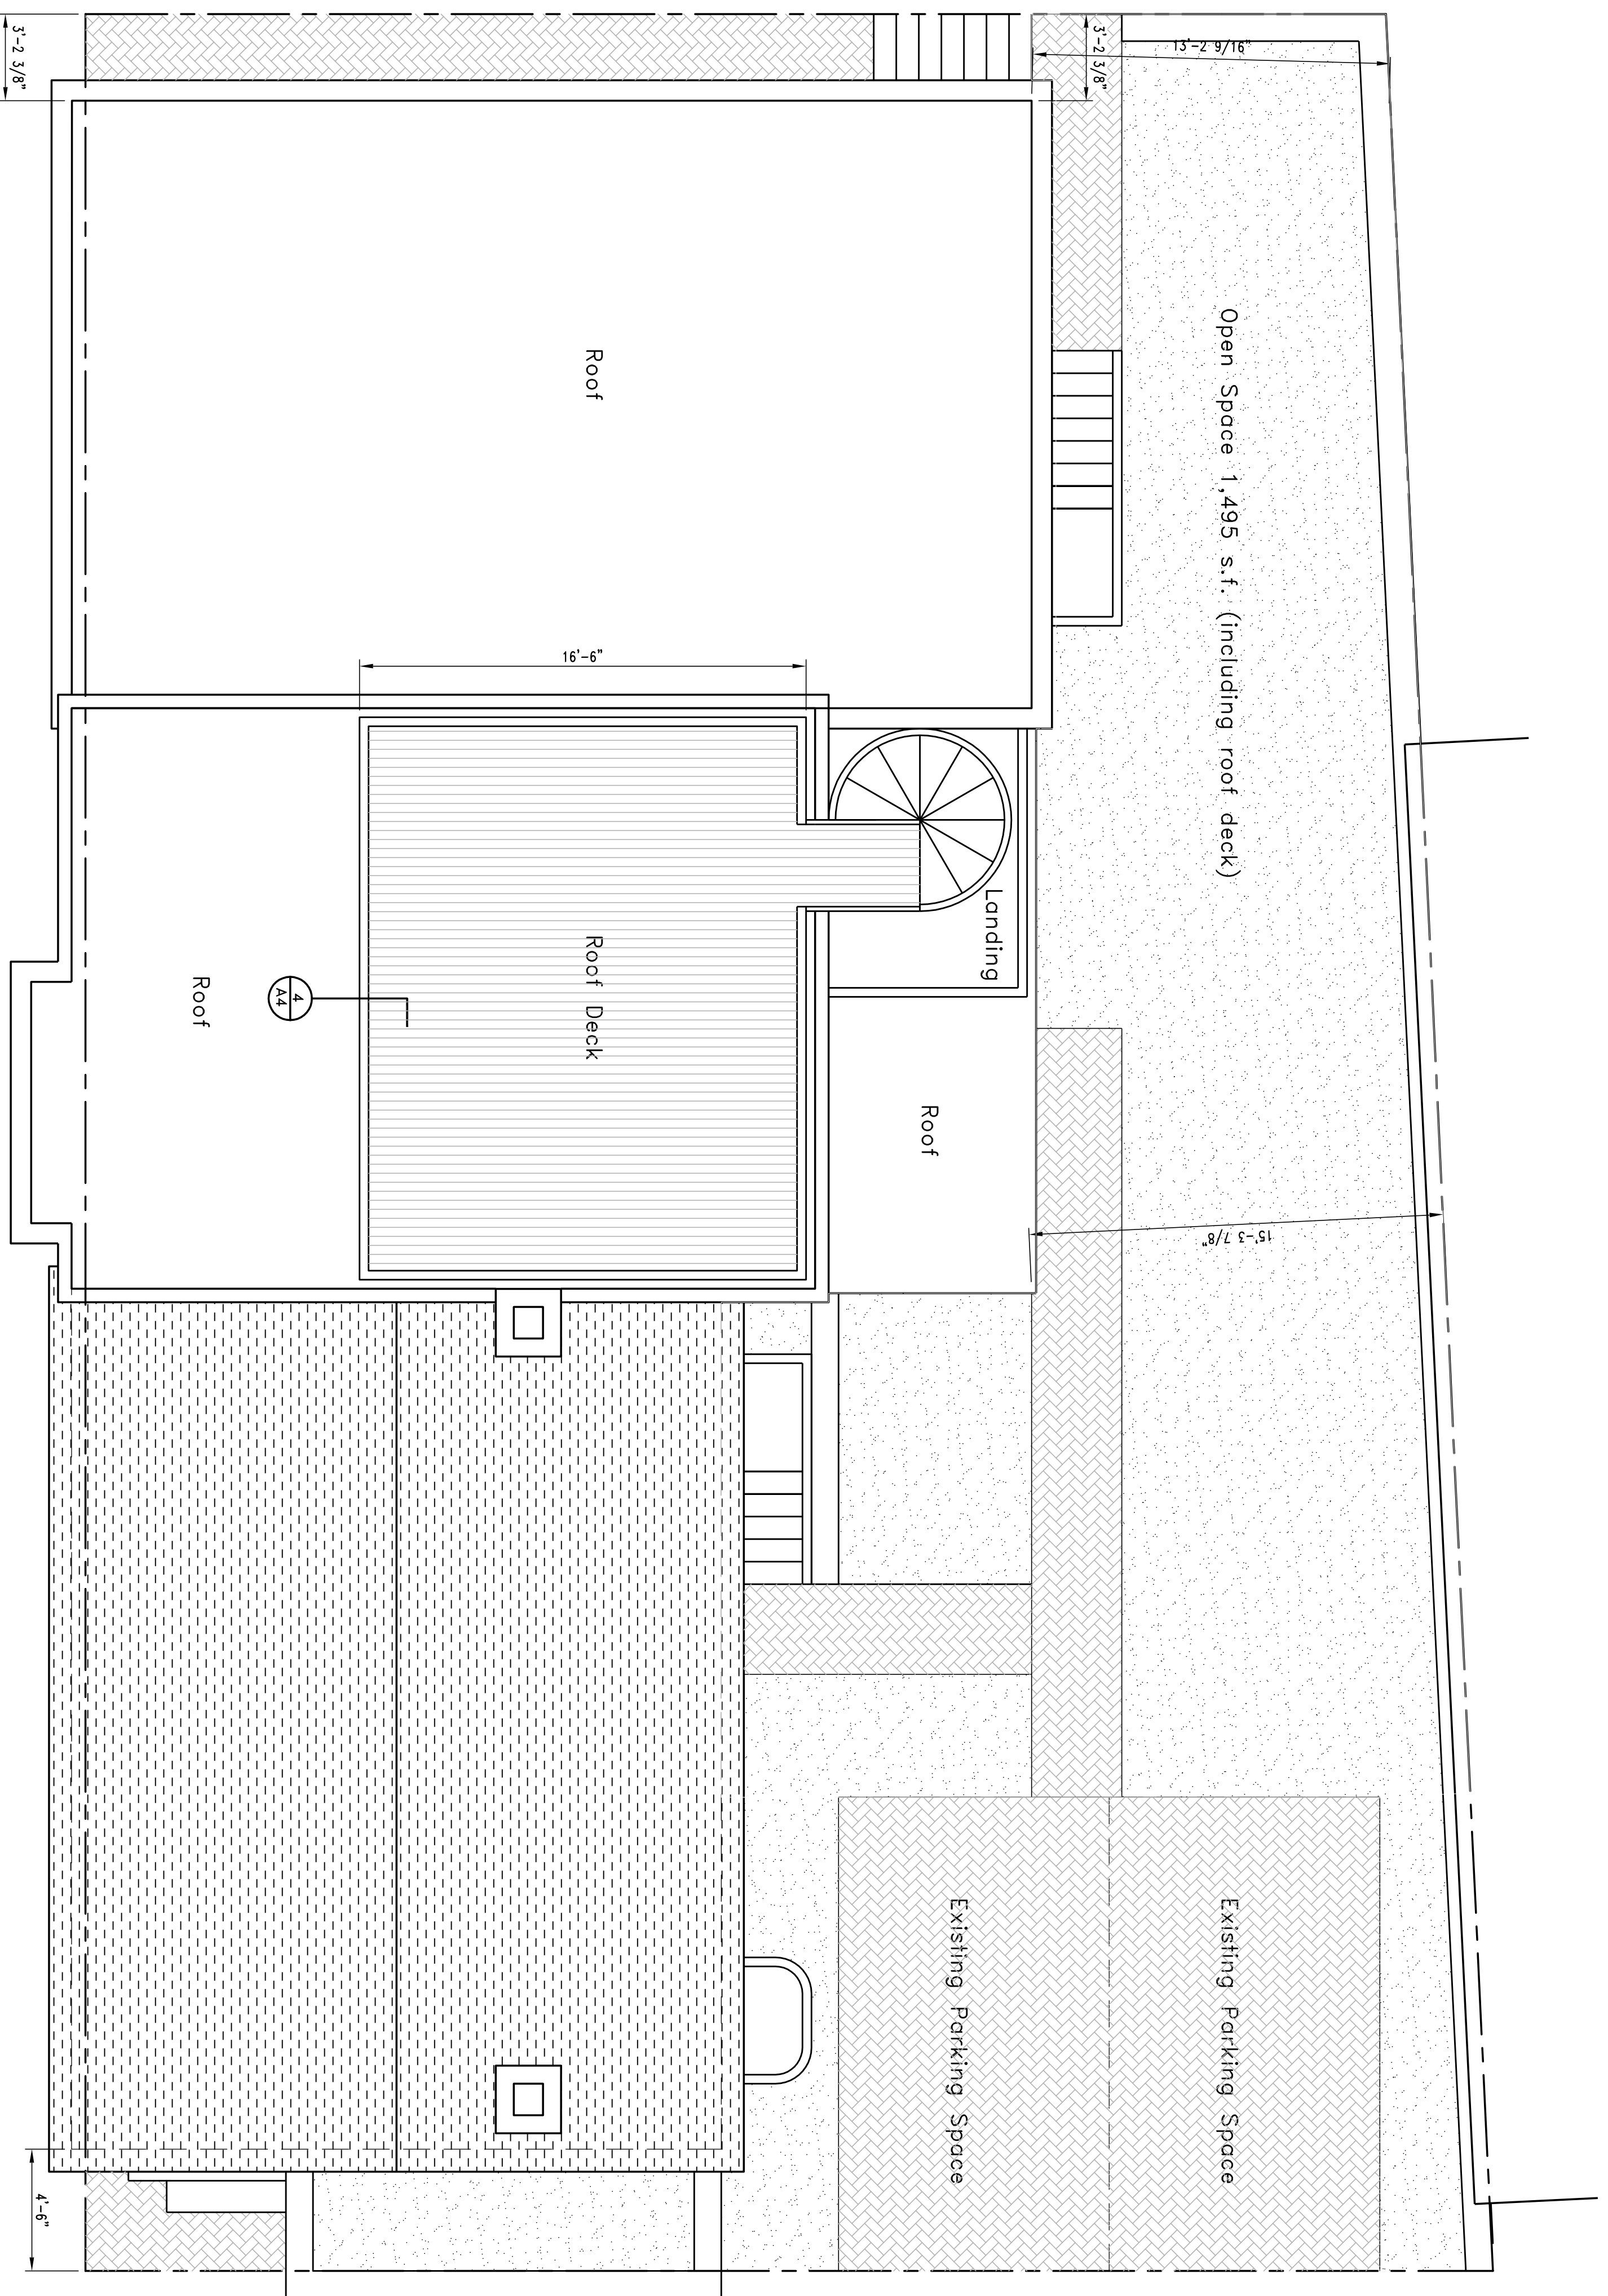


1 Architectural Site Plan
Scale: 1/4" = 1'-0"

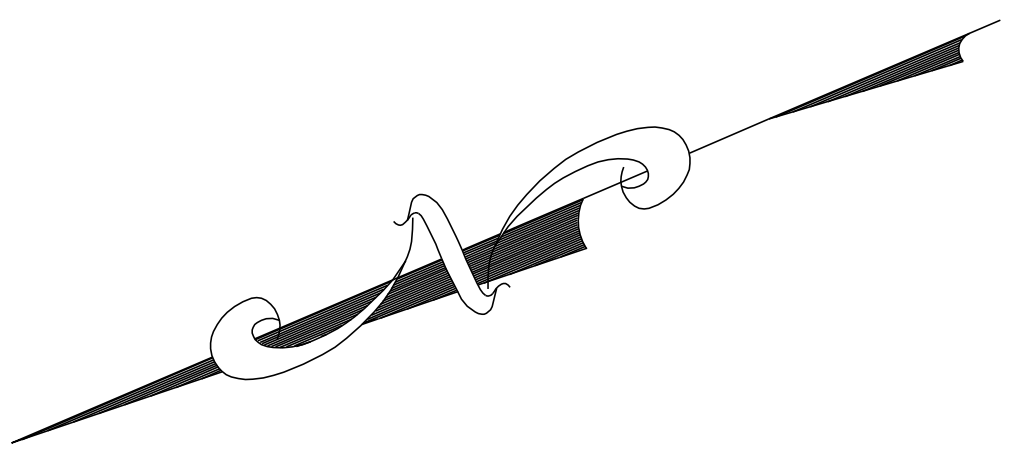

North arrow

AESTHETIC IMAGES
Architects / Planners
7 Stimson Street
Boston, Massachusetts 02132
Phone: (617) 323-4955
Fax: (617) 323-6081

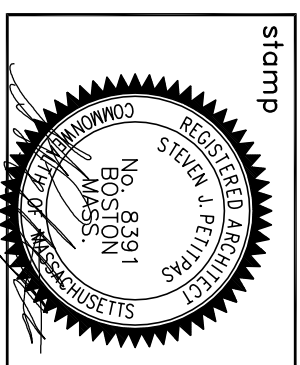

Project: Russell Street Town Houses
Russell Street
Charlestown, Massachusetts

Revisions	Date	By	For

Date	04/21/2016
Scale	1/4" = 1'-0"
Drawn	SJP
Job no.	

Title: Architectural Site Plan

Sheet no.

11

